


KEY PLAN




LEGEND

-  MUSTER STATION
-  DESIGNATED EMERGENCY ASSEMBLY AREA
-  SMOKING AREA

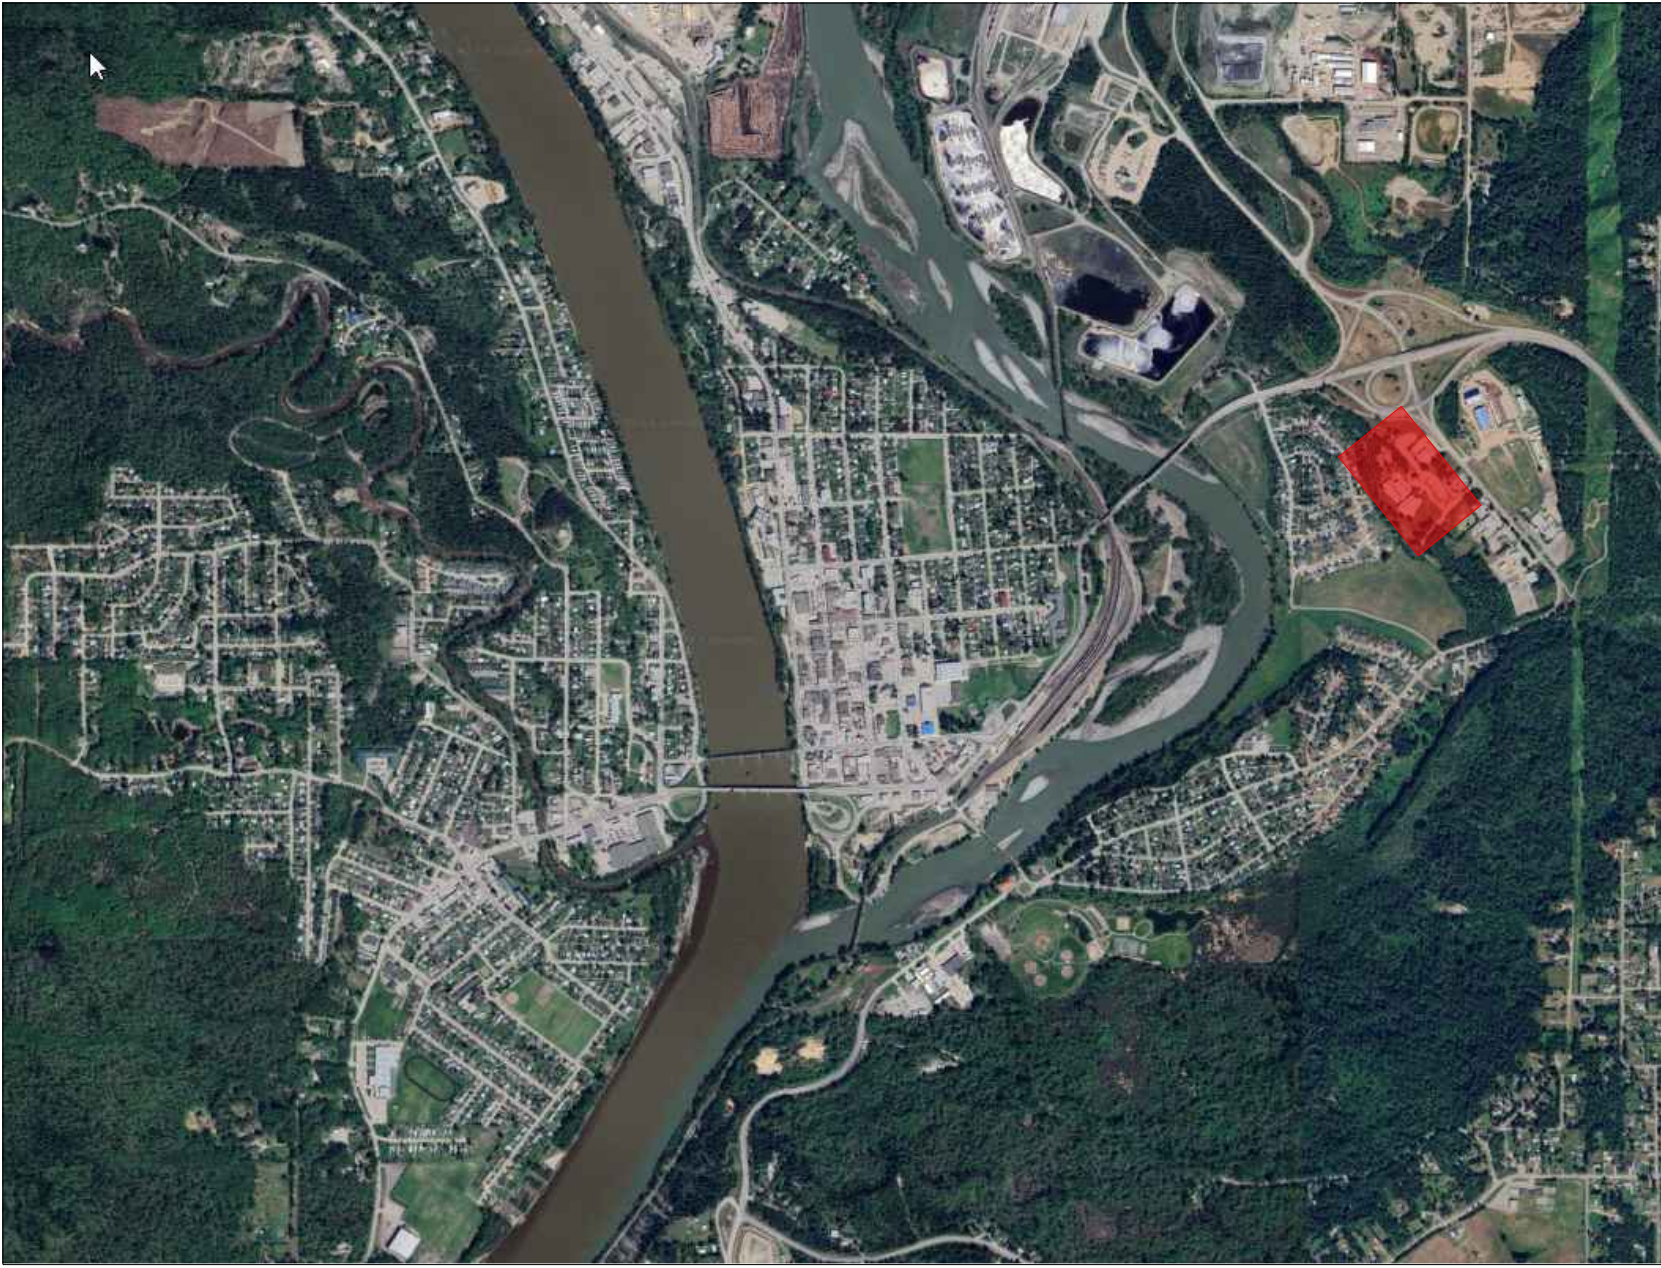

DR. BY:	ROOM NO:	REVISION NO:	REVISION TITLE:
NO:	SCALE:	REVISION NO:	REVISION TITLE:
DATE: JULY 2024	SHEET:	OF:	REVISION TITLE:
LOCATION: QUESNEL, BRITISH COLUMBIA			

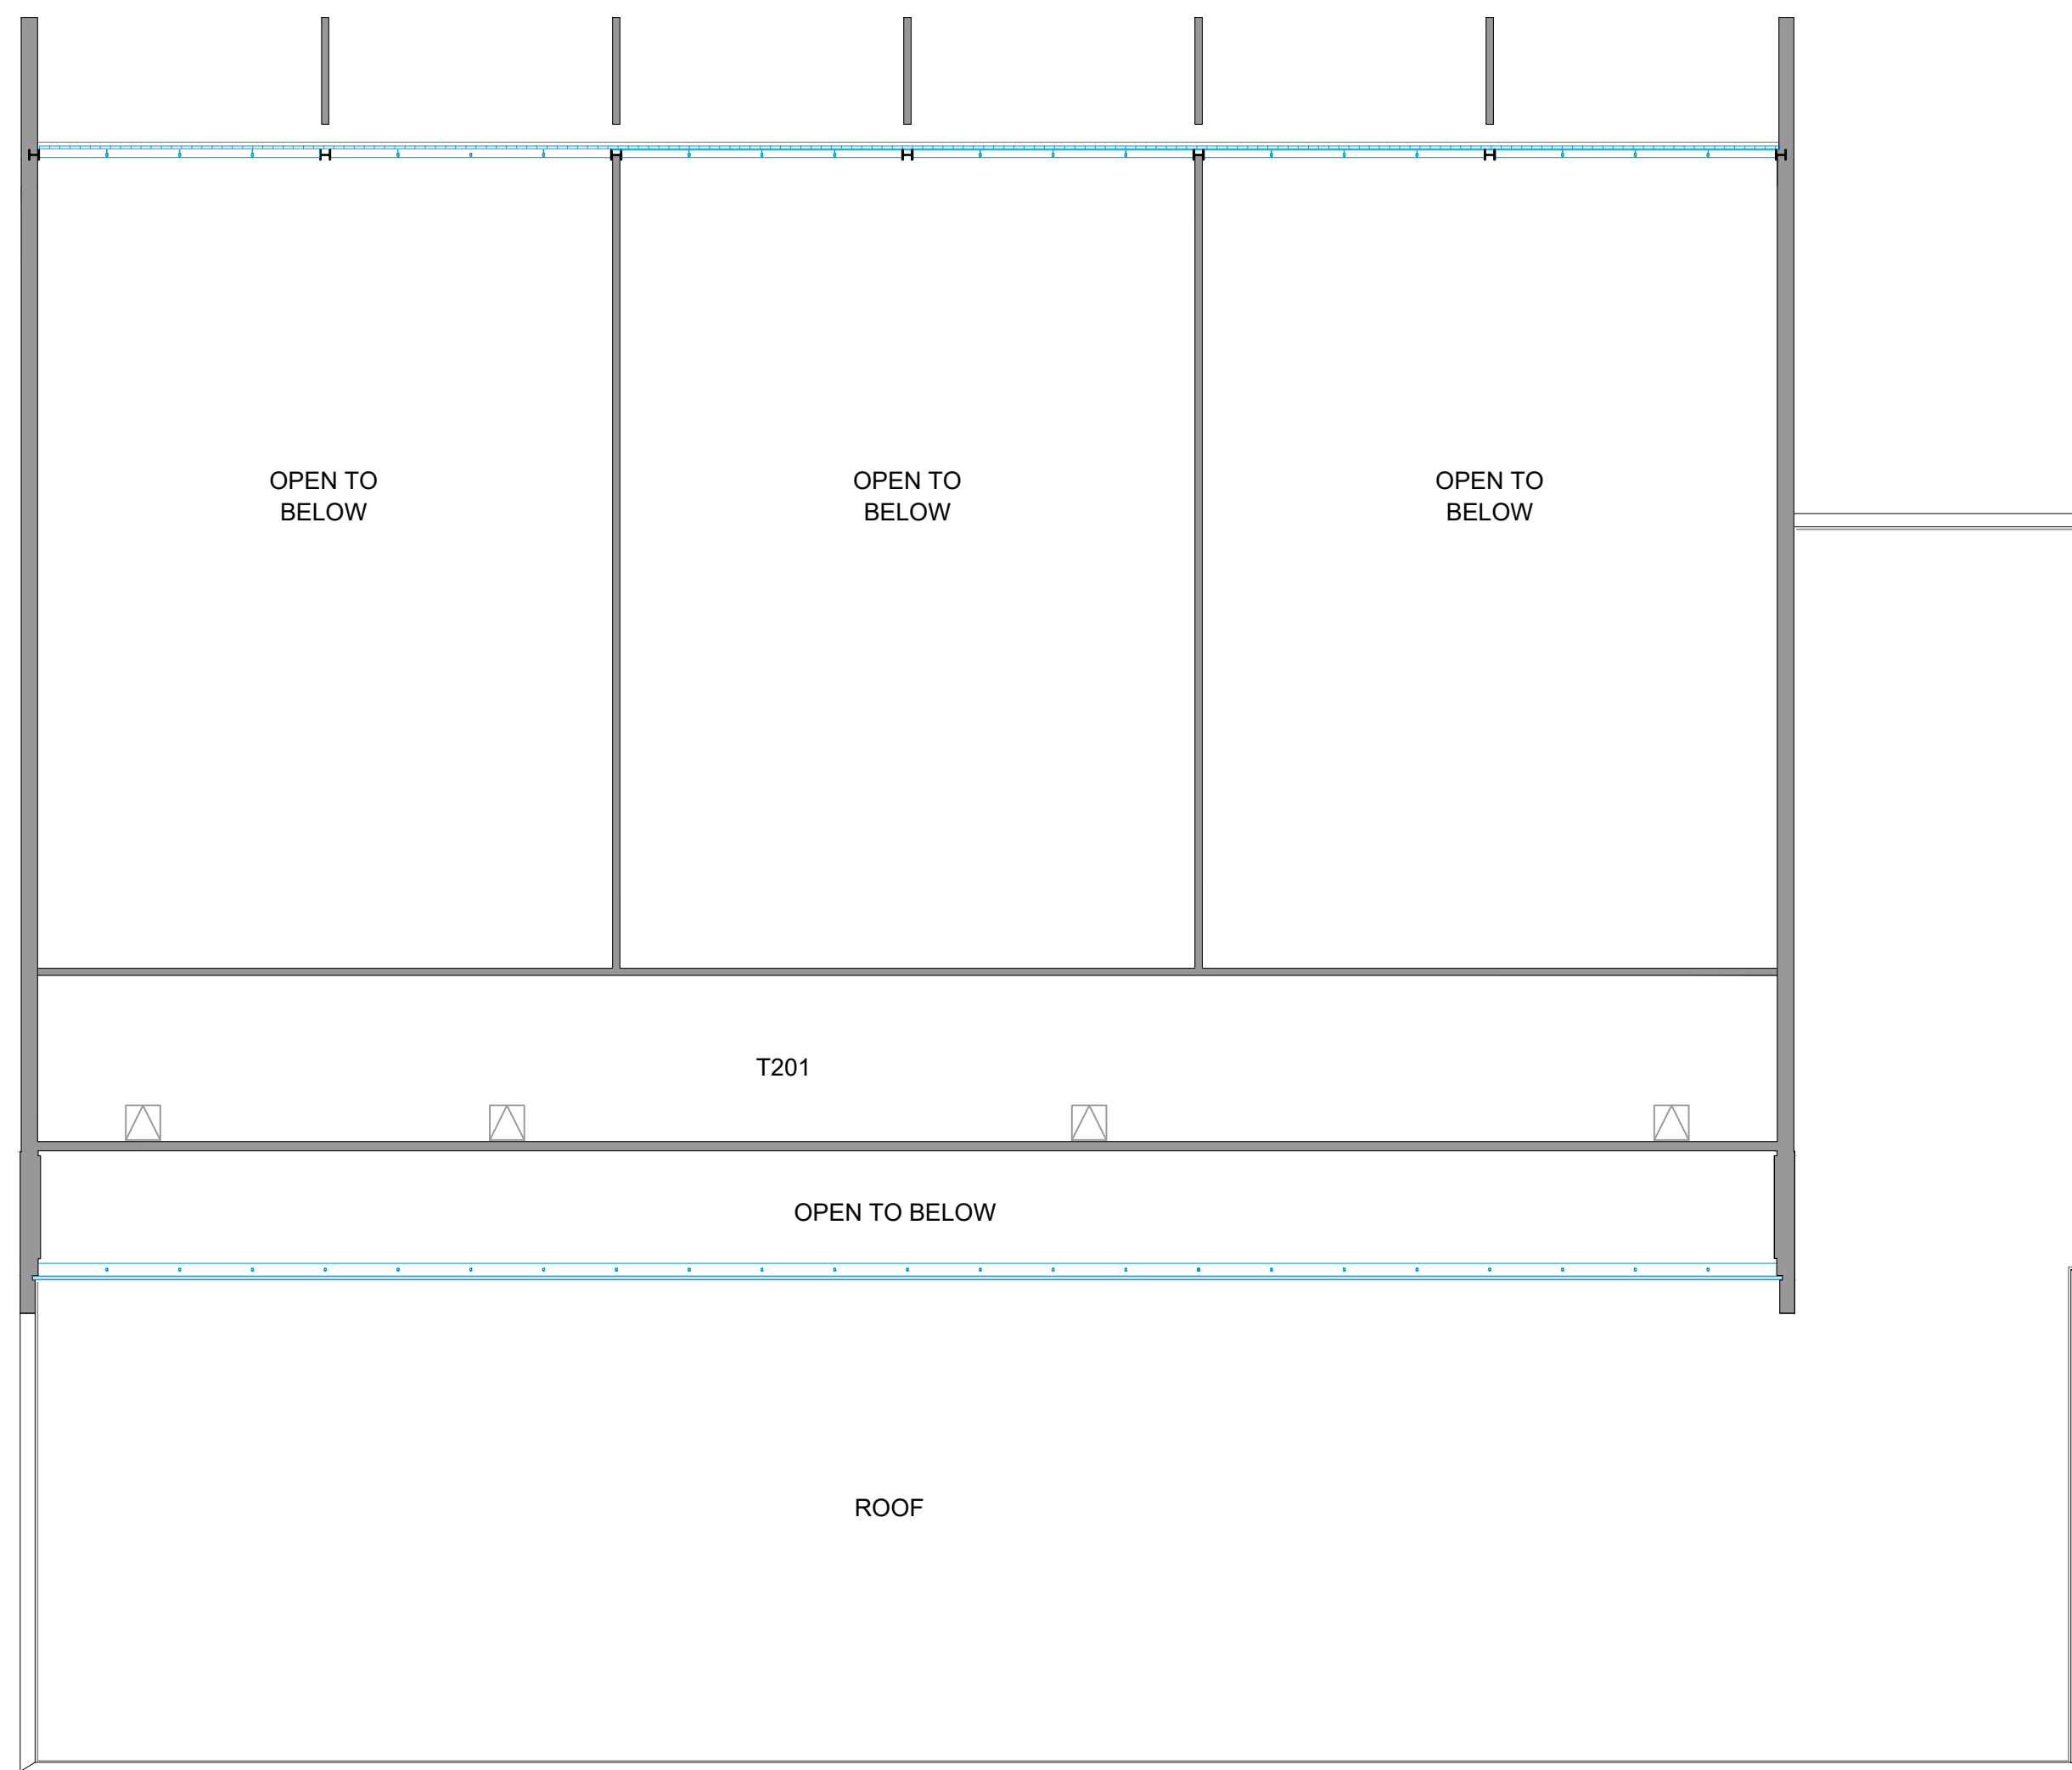

1
A-02 QUESNEL BUILDING - LEVEL 2
NTS



College of New Caledonia

Facility Services, Room 2-332, 3330 - 22nd Avenue, Prince George, British Columbia
Tel (250) 561-5821, Fax (250) 561-5865, Web www.cnc.bc.ca

PROJECT: COLLEGE OF NEW CALEDONIA IN QUESNEL			
DWG. TITLE: QUESNEL BUILDING - FLOOR PLAN LEVEL 2			
DR. BY:	ROOM NO:	REVISION NO:	REVISION TITLE:
NO.:	SCALE: NTS	REVISION NO:	REVISION TITLE:
DATE: JAN, 2024	SHEET: 2 OF: 2	REVISION NO:	REVISION TITLE:
LOCATION: QUESNEL, BRITISH COLUMBIA			

Note:

SHEET NO.

A-02